


Locaties Sprinklerinstallatie YSL (Wateropslag en Pompen)

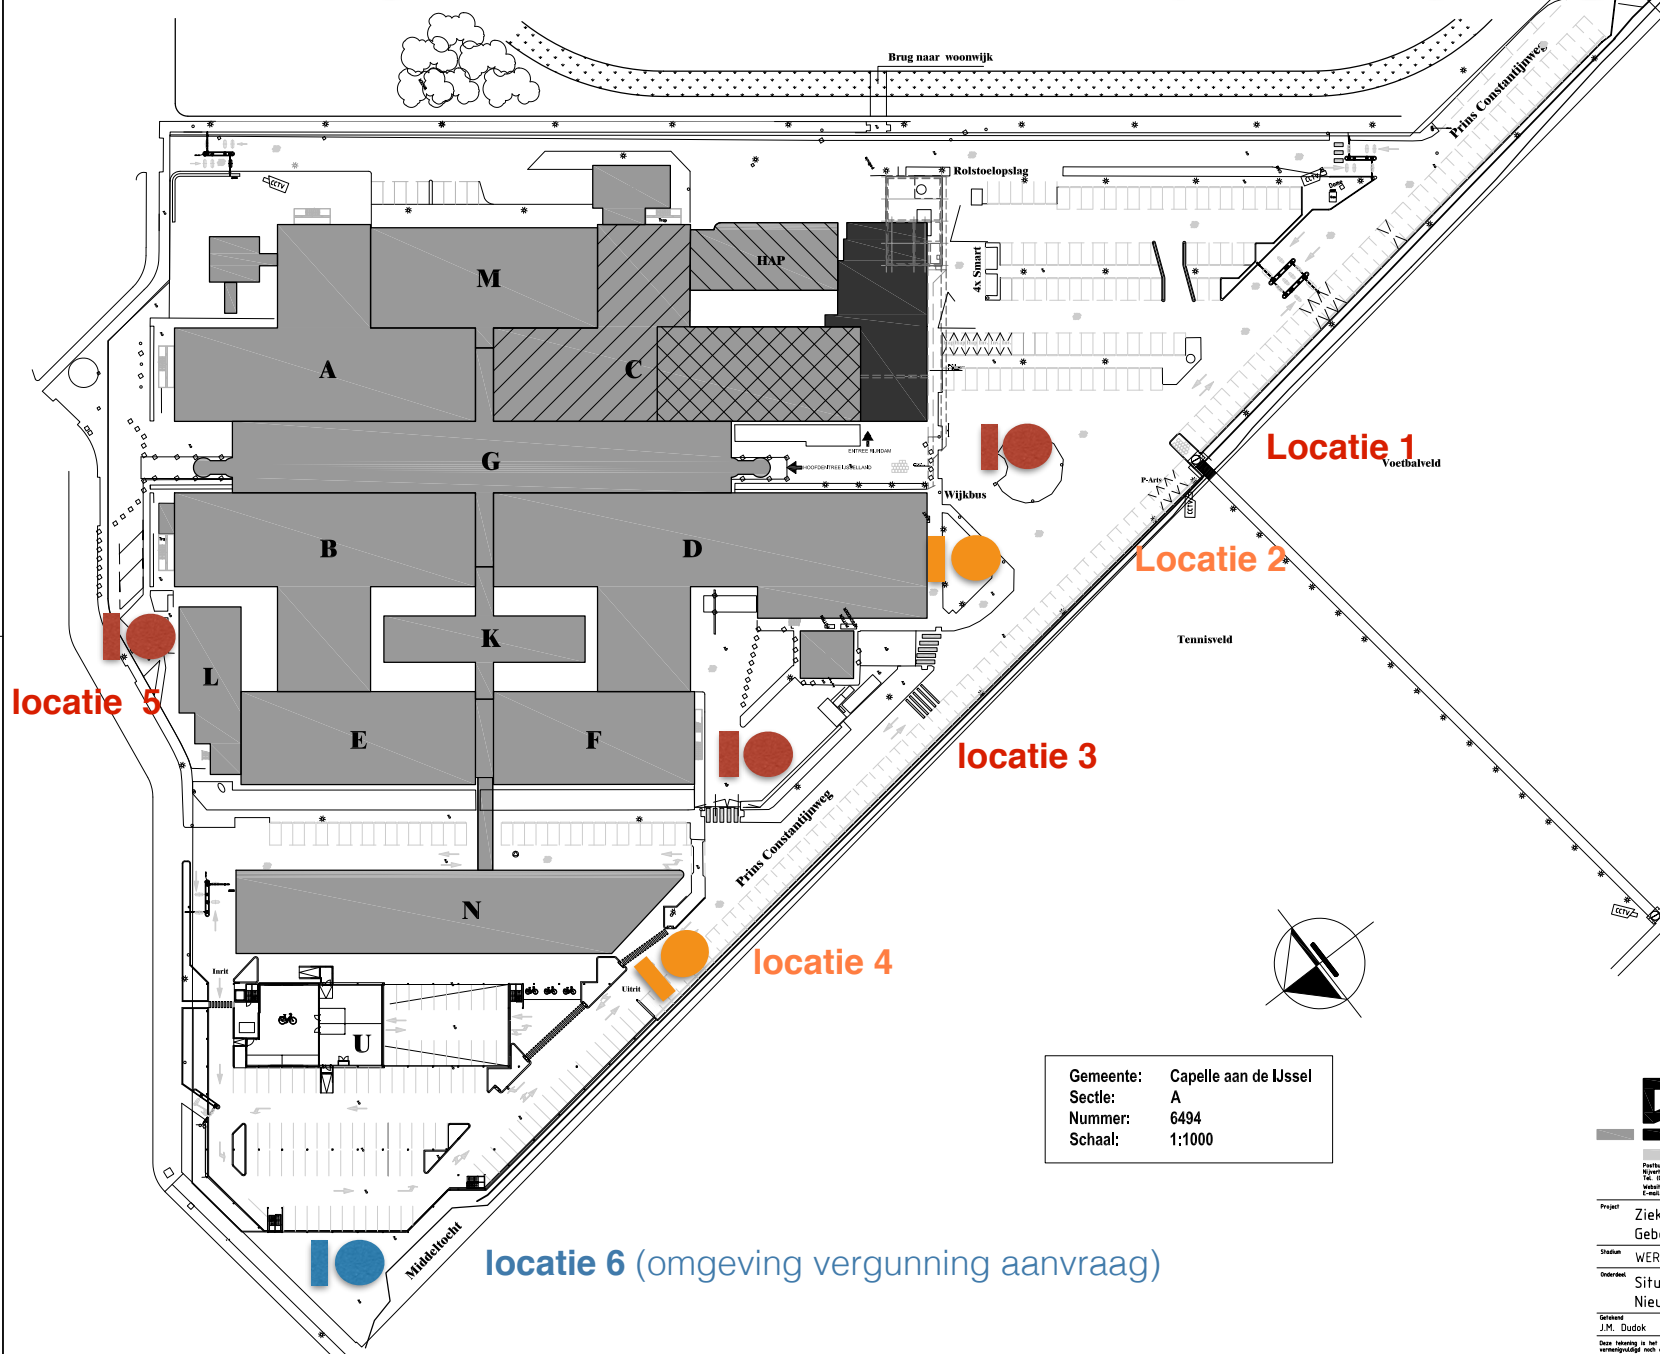

15895+P	DAK
12775+P	3e Verdieping
9625+P	2e Verdieping
6825+P	Technische Verdieping
3675+P	1e Verdieping
Afgesneden vloer: PEL=000+P	Begane Grond
1340 ÷ P	Kruipruimte

SITUATIE IJSSPELLAND ZIEKENHUIS

The site plan shows a complex of buildings labeled A through N. Building A is a large rectangular structure. Building M is a smaller structure adjacent to A. Building H is a shaded rectangular structure. Building G is a central structure with a cross-shaped extension. Building B is a rectangular structure. Building D is a rectangular structure. Building L is a rectangular structure. Building E is a rectangular structure. Building F is a rectangular structure. Building J is a rectangular structure. Building N is a large, irregularly shaped structure at the bottom. The plan is oriented with a compass rose indicating North (N) and a North arrow pointing towards the top right. The plan is labeled 'CARPENS-ZUIDE' on the left and 'ROTTERDAMS-ZUIDE' on the right.

Gemeente: Capelle aan de IJssel
 Sectie: A
 Nummer: 6494
 Schaal: 1:1000



Project		Ziekenhuis IJsselland Capelle aan den IJssel		Status
Gebouw C: Nieuwbouw Rijndam		revalidatie / OK's		
Situatie				
WERKTEKENING				
Onderwerp		Situatie		18-11-2013
Nieuwe toestand				
Schets	Detail	Schaal	Formaat	Projectnummer
J.H. Boudok		1:500	A3	131850
Dit "tekenblad" is afkomstig van SPANINGS ROUWSTUUF BV, en mag niet apart gebruikt worden.				
				Tekening
				W-00