
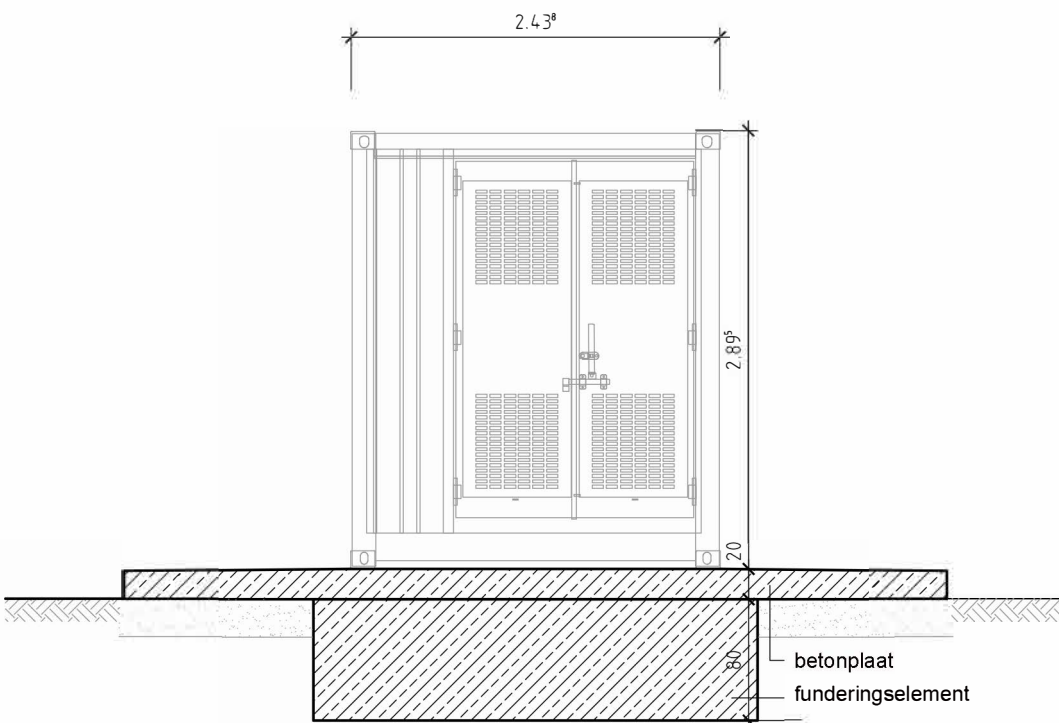


Bijlage G: Specificaties Technische Installatie


Transformator- en omvormerstation

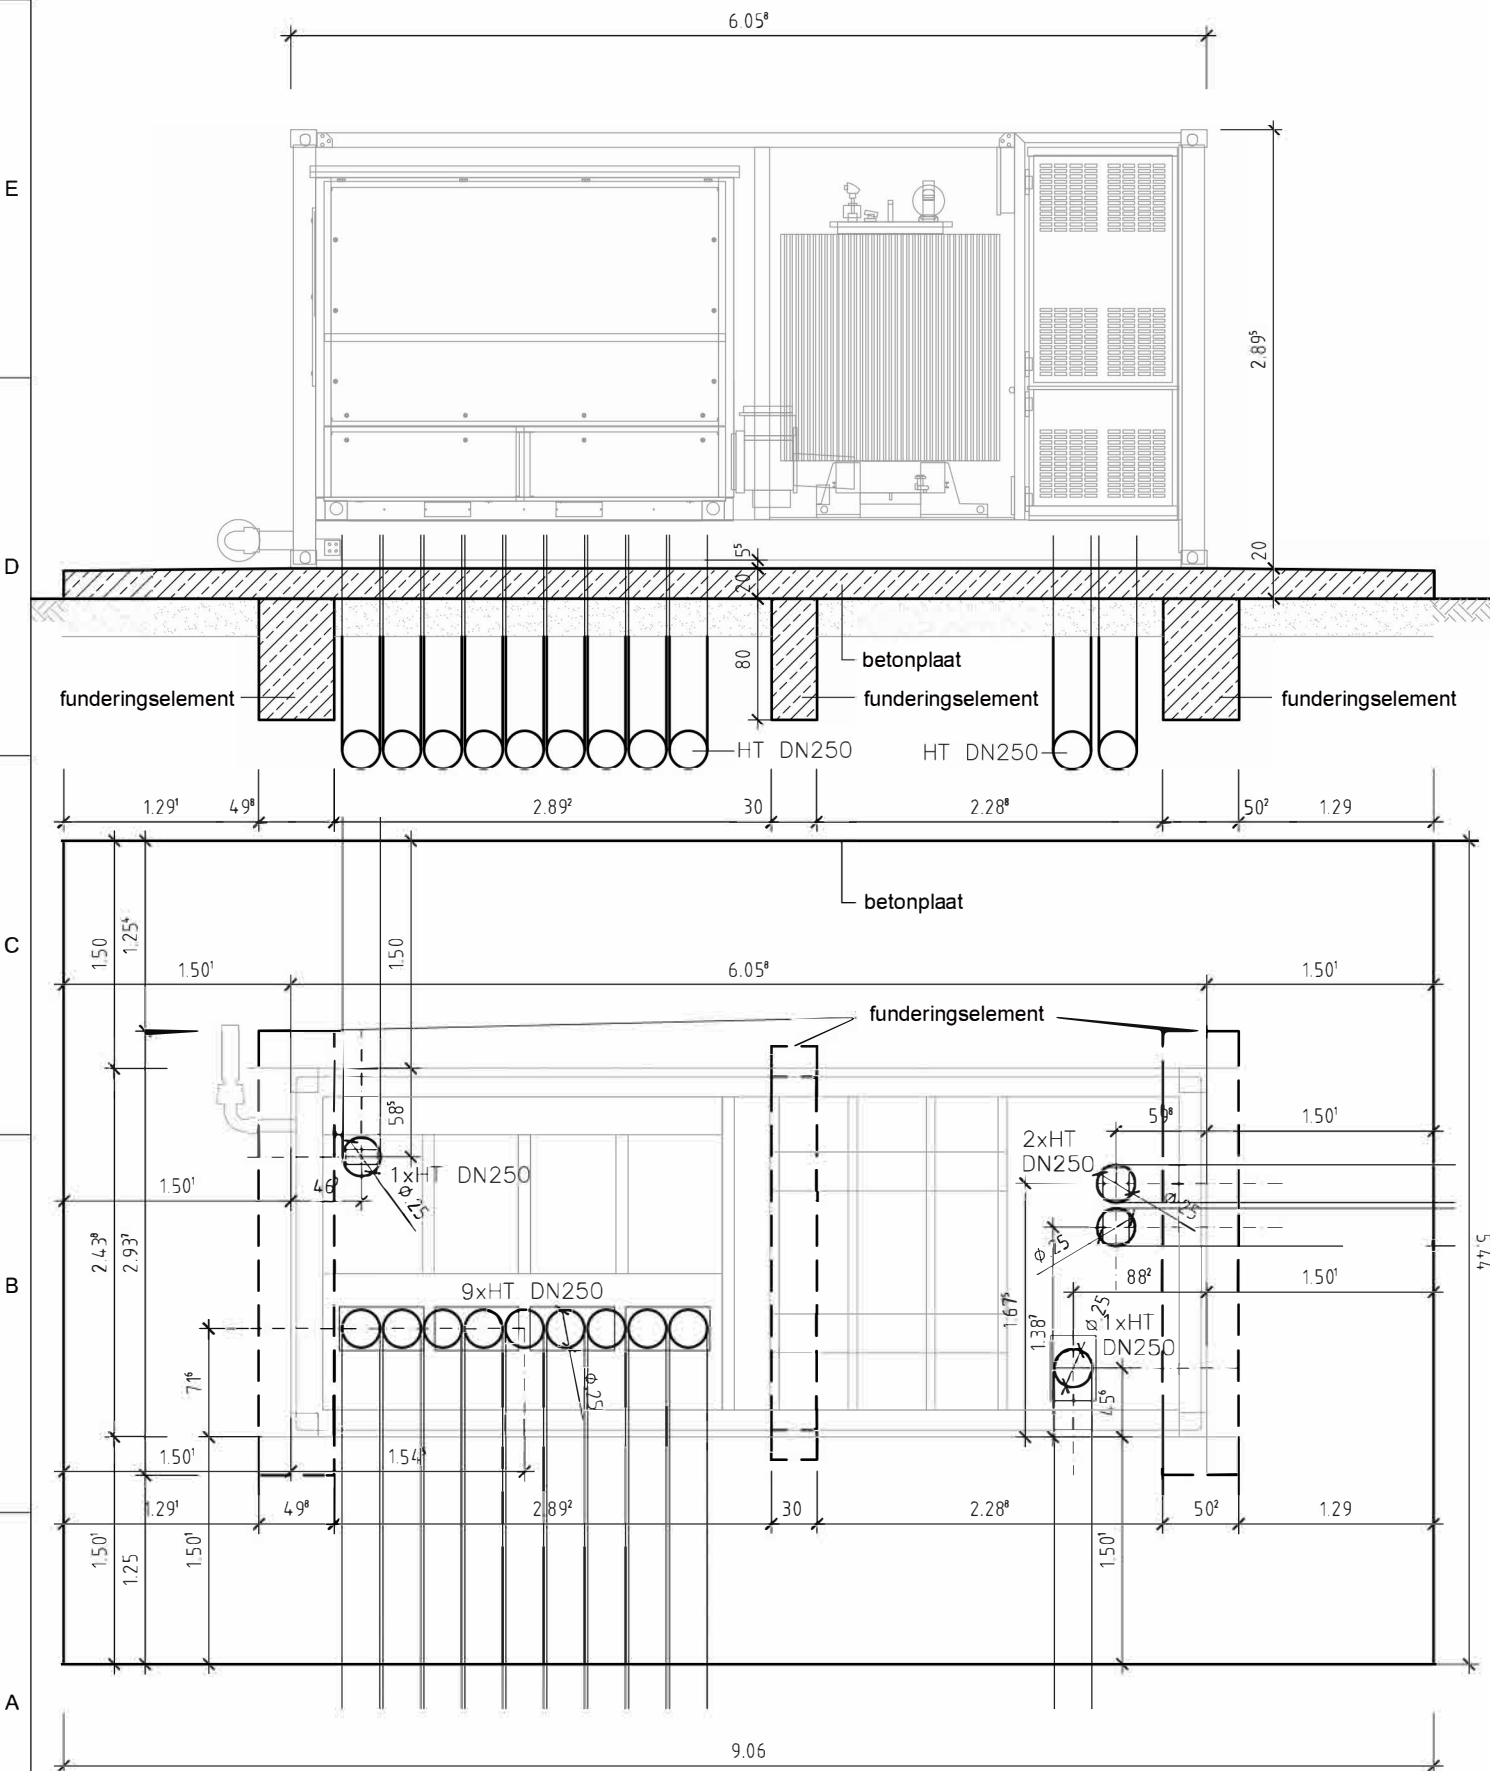







Kleur : RAL 7004

scale:

customer TPSolar-Konzept B.V. Melbournestraat 9 1175 RM Lijnden 					date	name	drawing number		19-171_EK01	
				edit	01.04.2020	Ko	project		PV power plant	
				draw	01.04.2020	Ko/AB				
				check						
index	revision	date	name	 e4r - engineers for renewables GmbH Poststr. 11-12 10178 Berlin T +49 (0) 30 4372 5105 M contact@e-4-r.de all rights reserved			planning state		draft	
							drawing		station foundation	
							version		scale	
									1:50	
							page 1/1		format	
									A3	

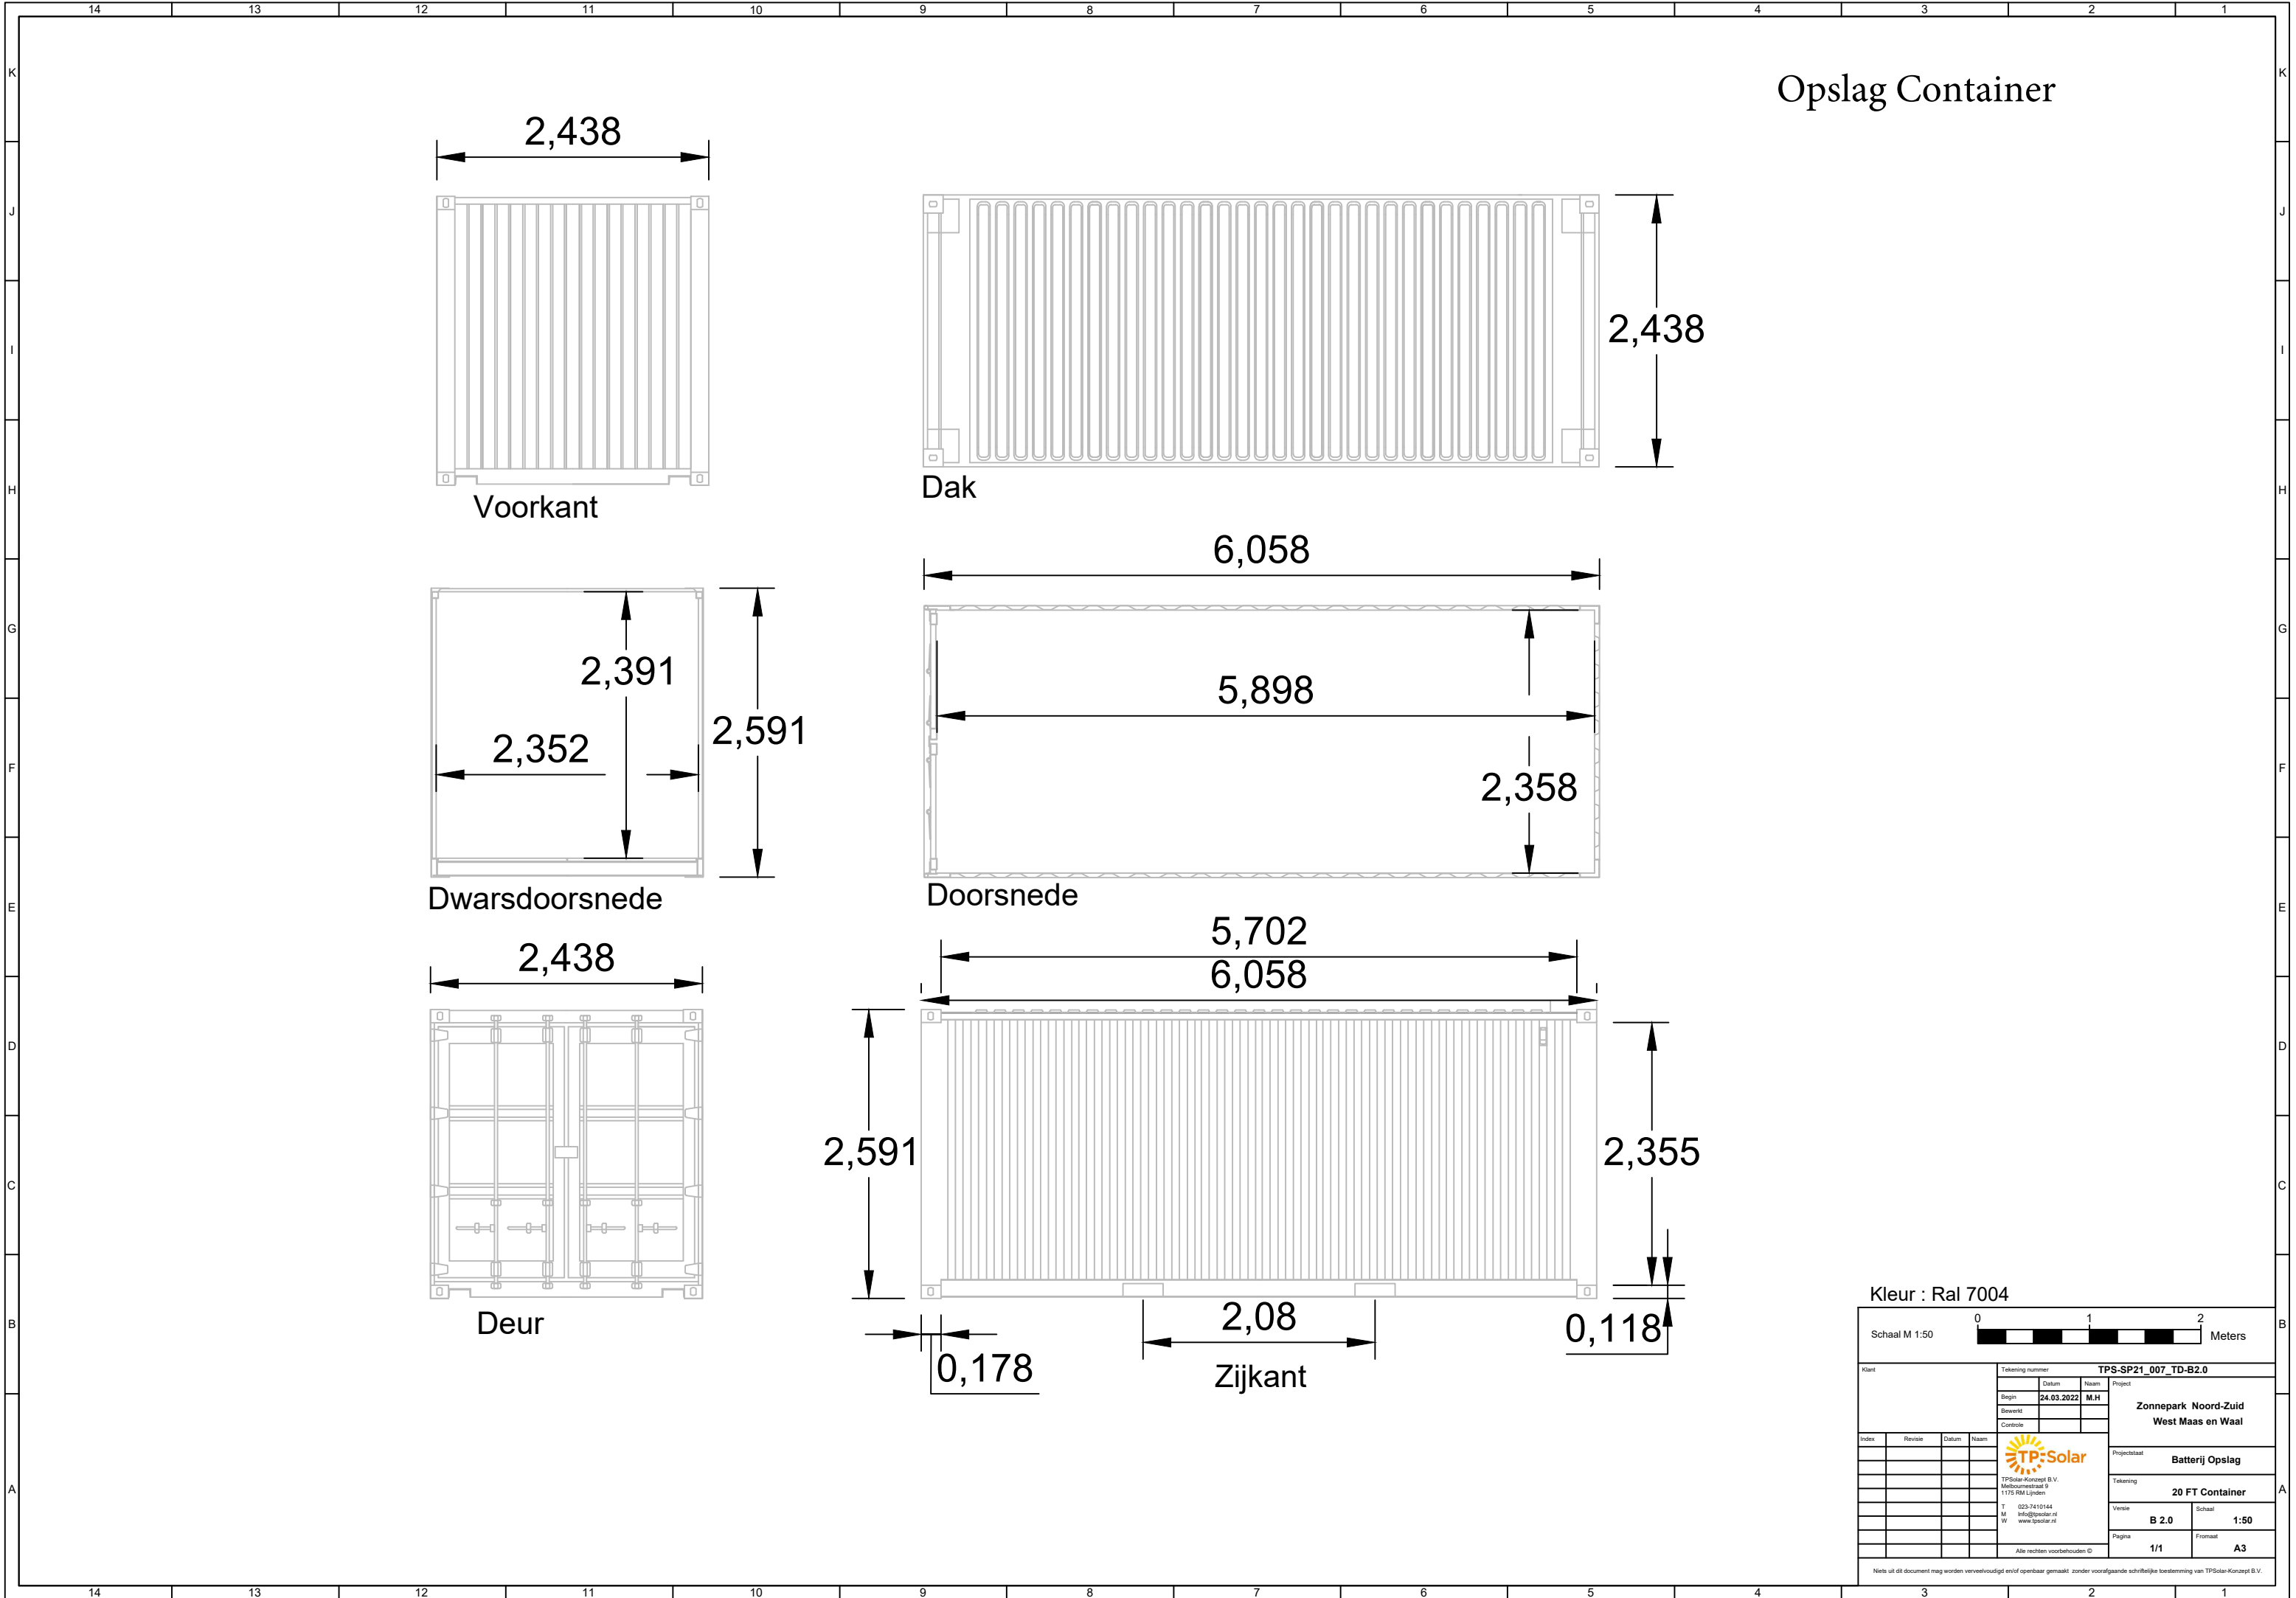

Opslag Container

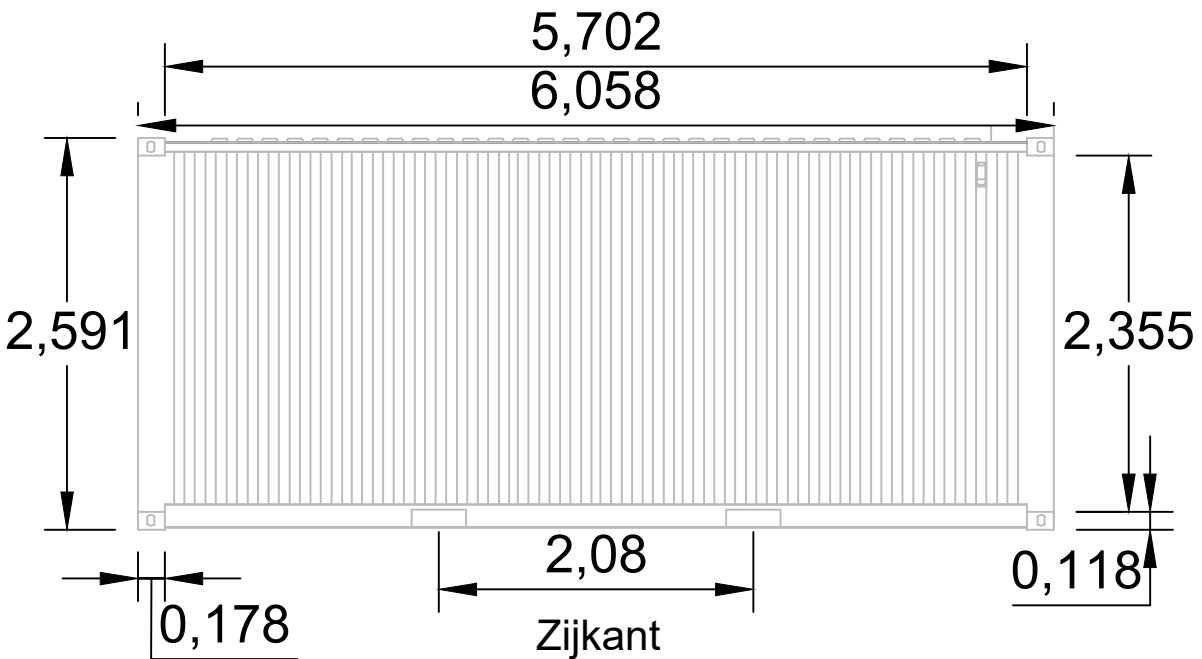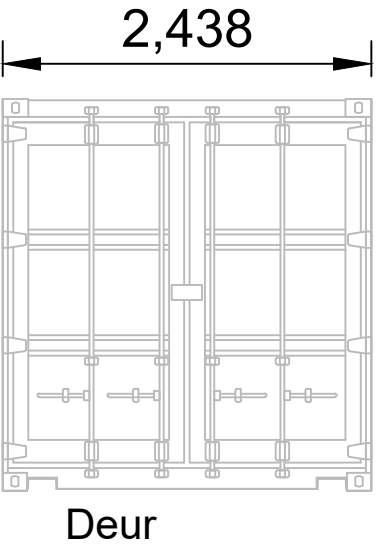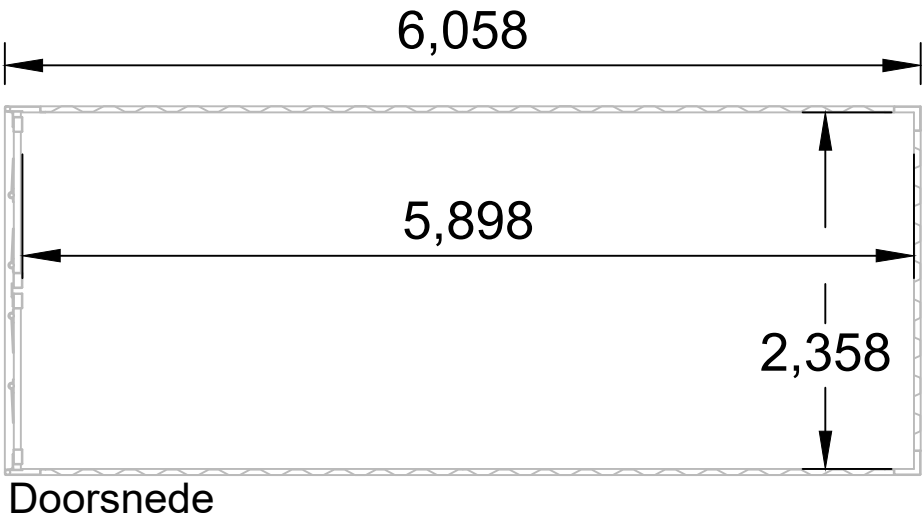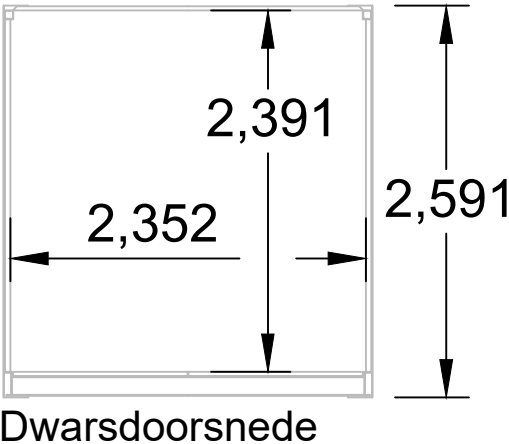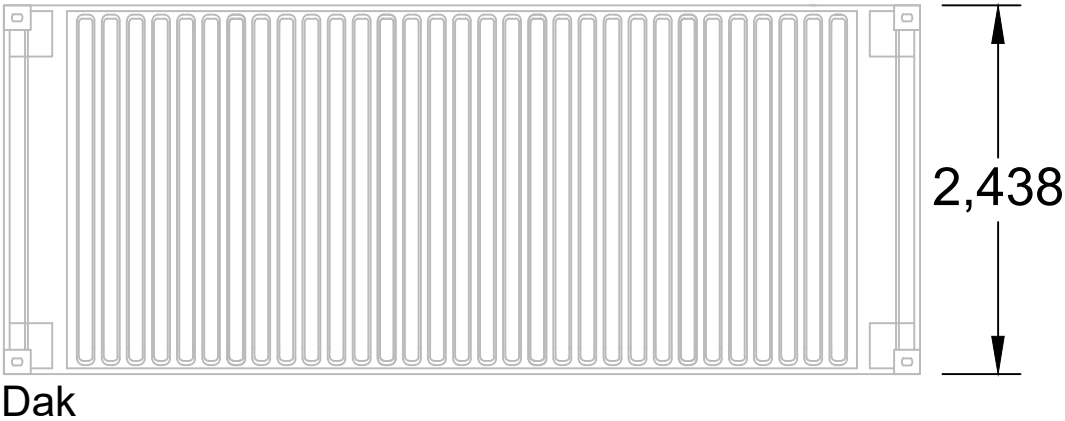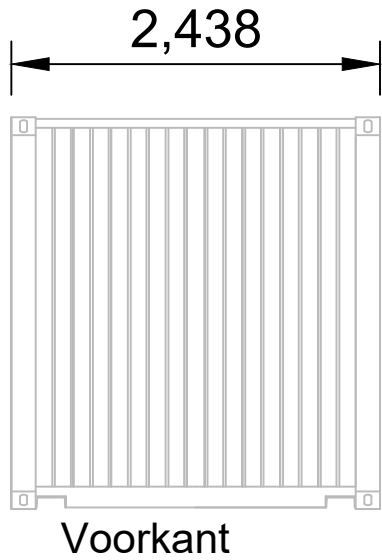

Kleur : Ral 7004

Schaal M 1:50

0 1 2 Meters

Klant	Tekening nummer			TPS-SP21_007_TD-B2.0	
	Begin	Datum	Naam	Project	
	24.03.2022		M.H	Zonnepark Noord-Zuid	
	Bewerkt			West Maas en Waal	
	Controle			Projectleider	
				Batterij Opslag	
				Tekening	
				20 FT Container	
				Versie	Schaal
				B 2.0	1:50
				Pagina	Formaat
				1/1	A3
Alle rechten voorbehouden ©					
Niets uit dit document mag worden vervoelvoudigd en/of openbaar gemaakt zonder voorafgaande schriftelijke toestemming van TPSolar-Konzept B.V.					

